


Drawing Contents

Drawing No.	Drawing Name
01.1	Cover Page
01.2	Site Plan
01.3	Ground Floor Plan
01.4	Electrical Plan
02.1	Elevations
03.1	Section A

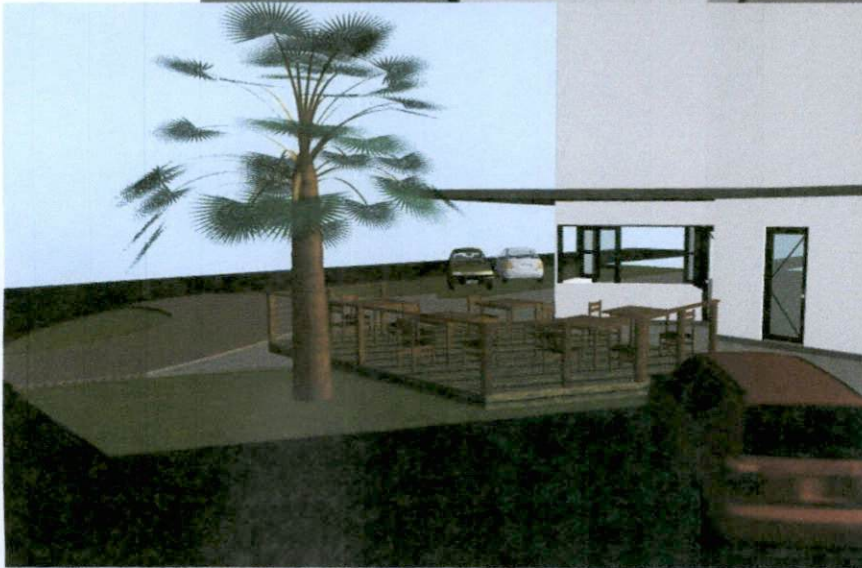

Issue: DA 2

PROPOSED CURBSIDE DINING DECK

Cover Page

Scale:1:0

Date: 31/04/2018

TARGA RESTAURANT, 11 MARVELL ST. BYRON BAY

Drawn By: JS

Drawing:01.1



Issue: DA 2

PROPOSED CURBSIDE DINING DECK

Site Plan


Scale: 1:200@A3

Date: 31/04/2018

TARGA RESTAURANT, 11 MARVELL ST. BYRON BAY

Drawn By: JS

Drawing: 01.2

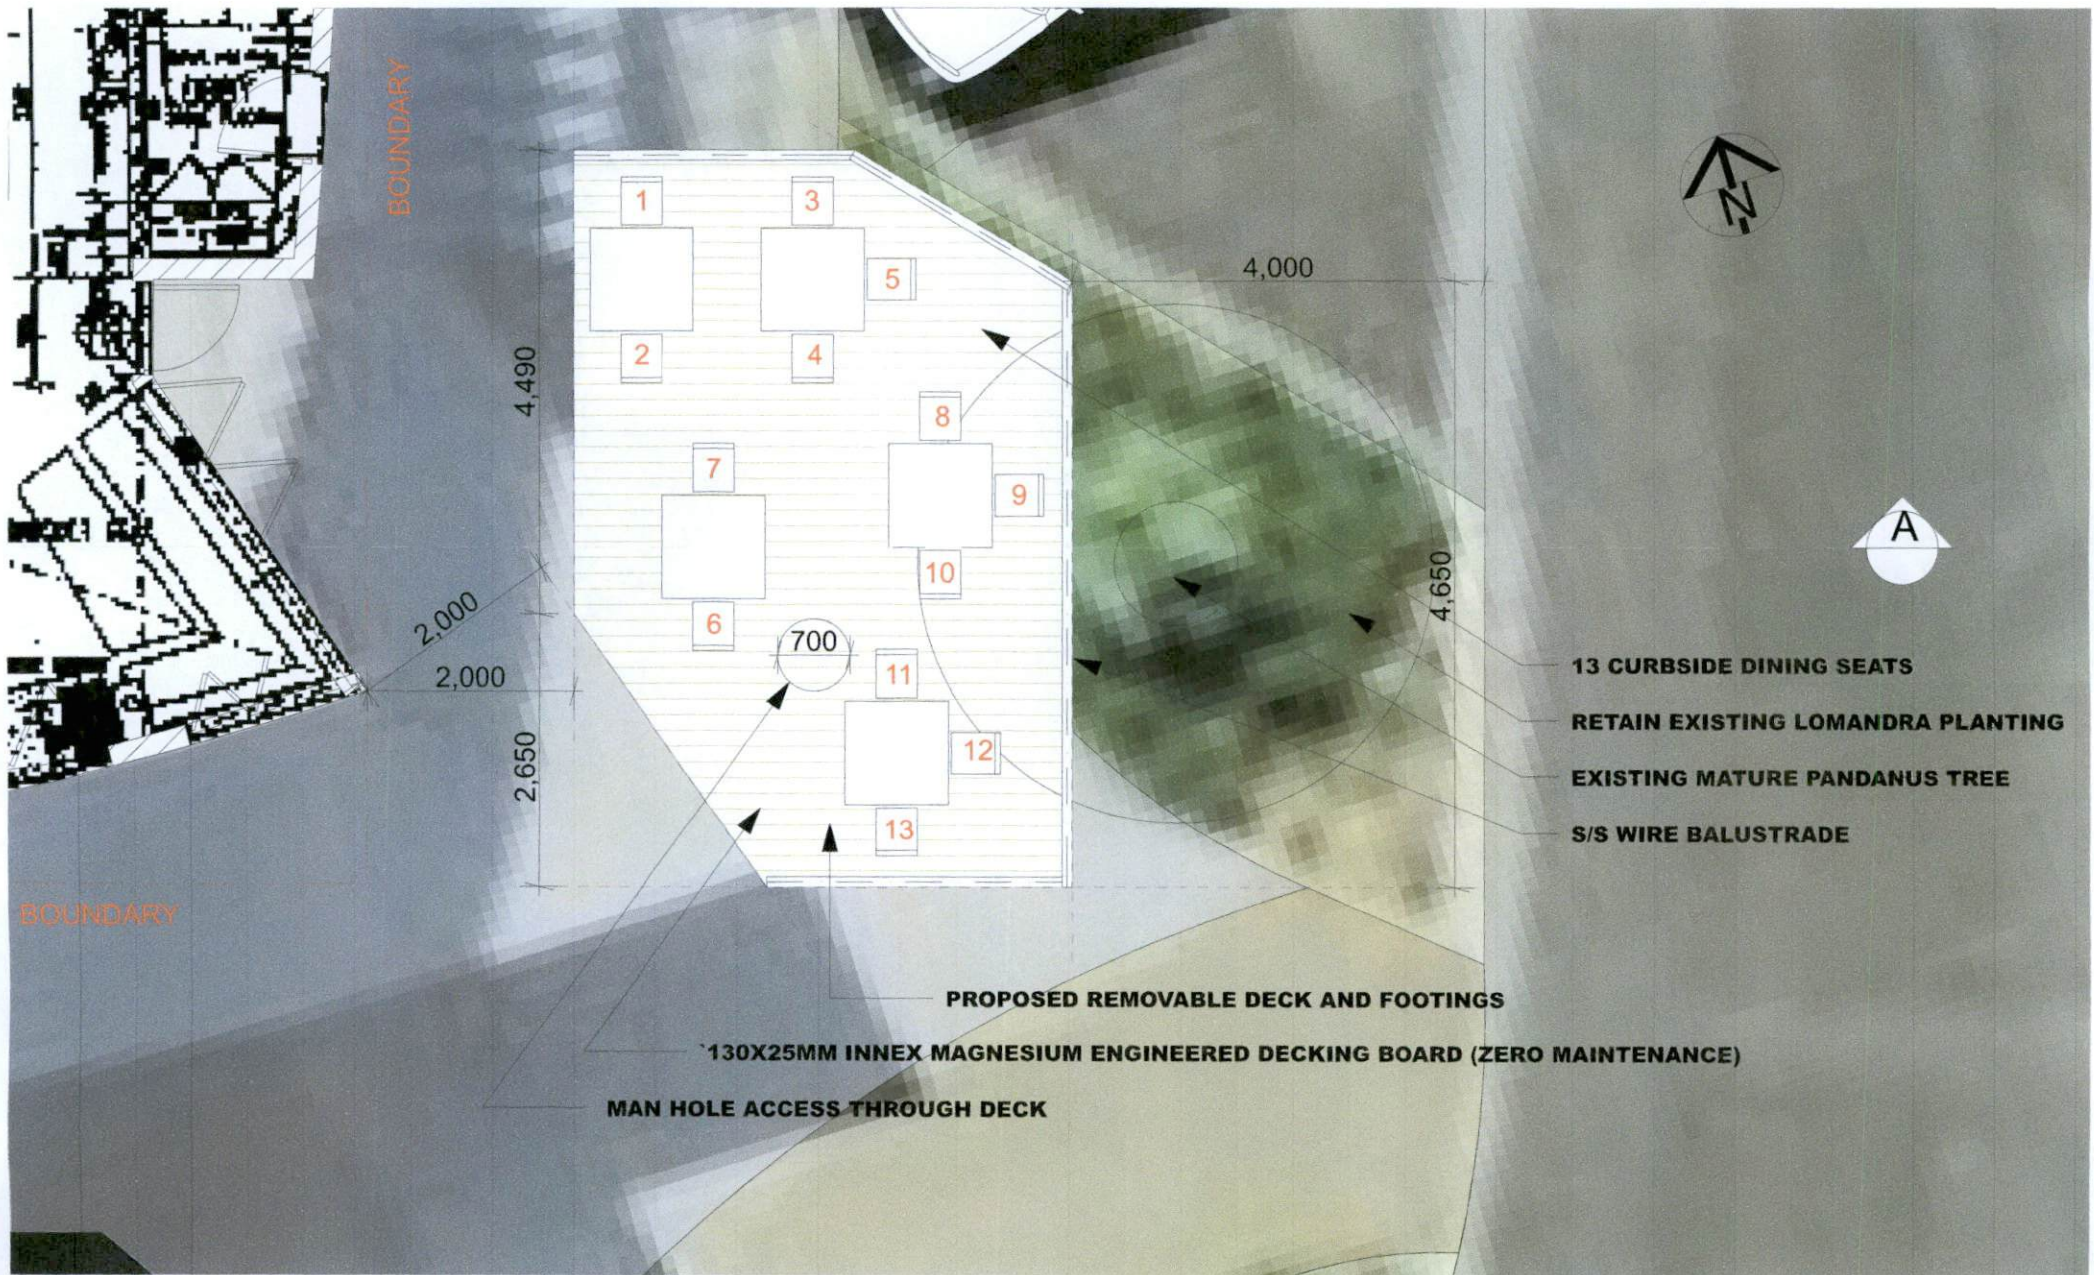

Issue: DA 2

PROPOSED CURBSIDE DINING DECK

Ground Floor Plan


Scale: 1:50@A3

Date: 31/04/2018

TARGA RESTAURANT, 11 MARVELL ST. BYRON BAY

Drawn By: JS

Drawing: 01.3

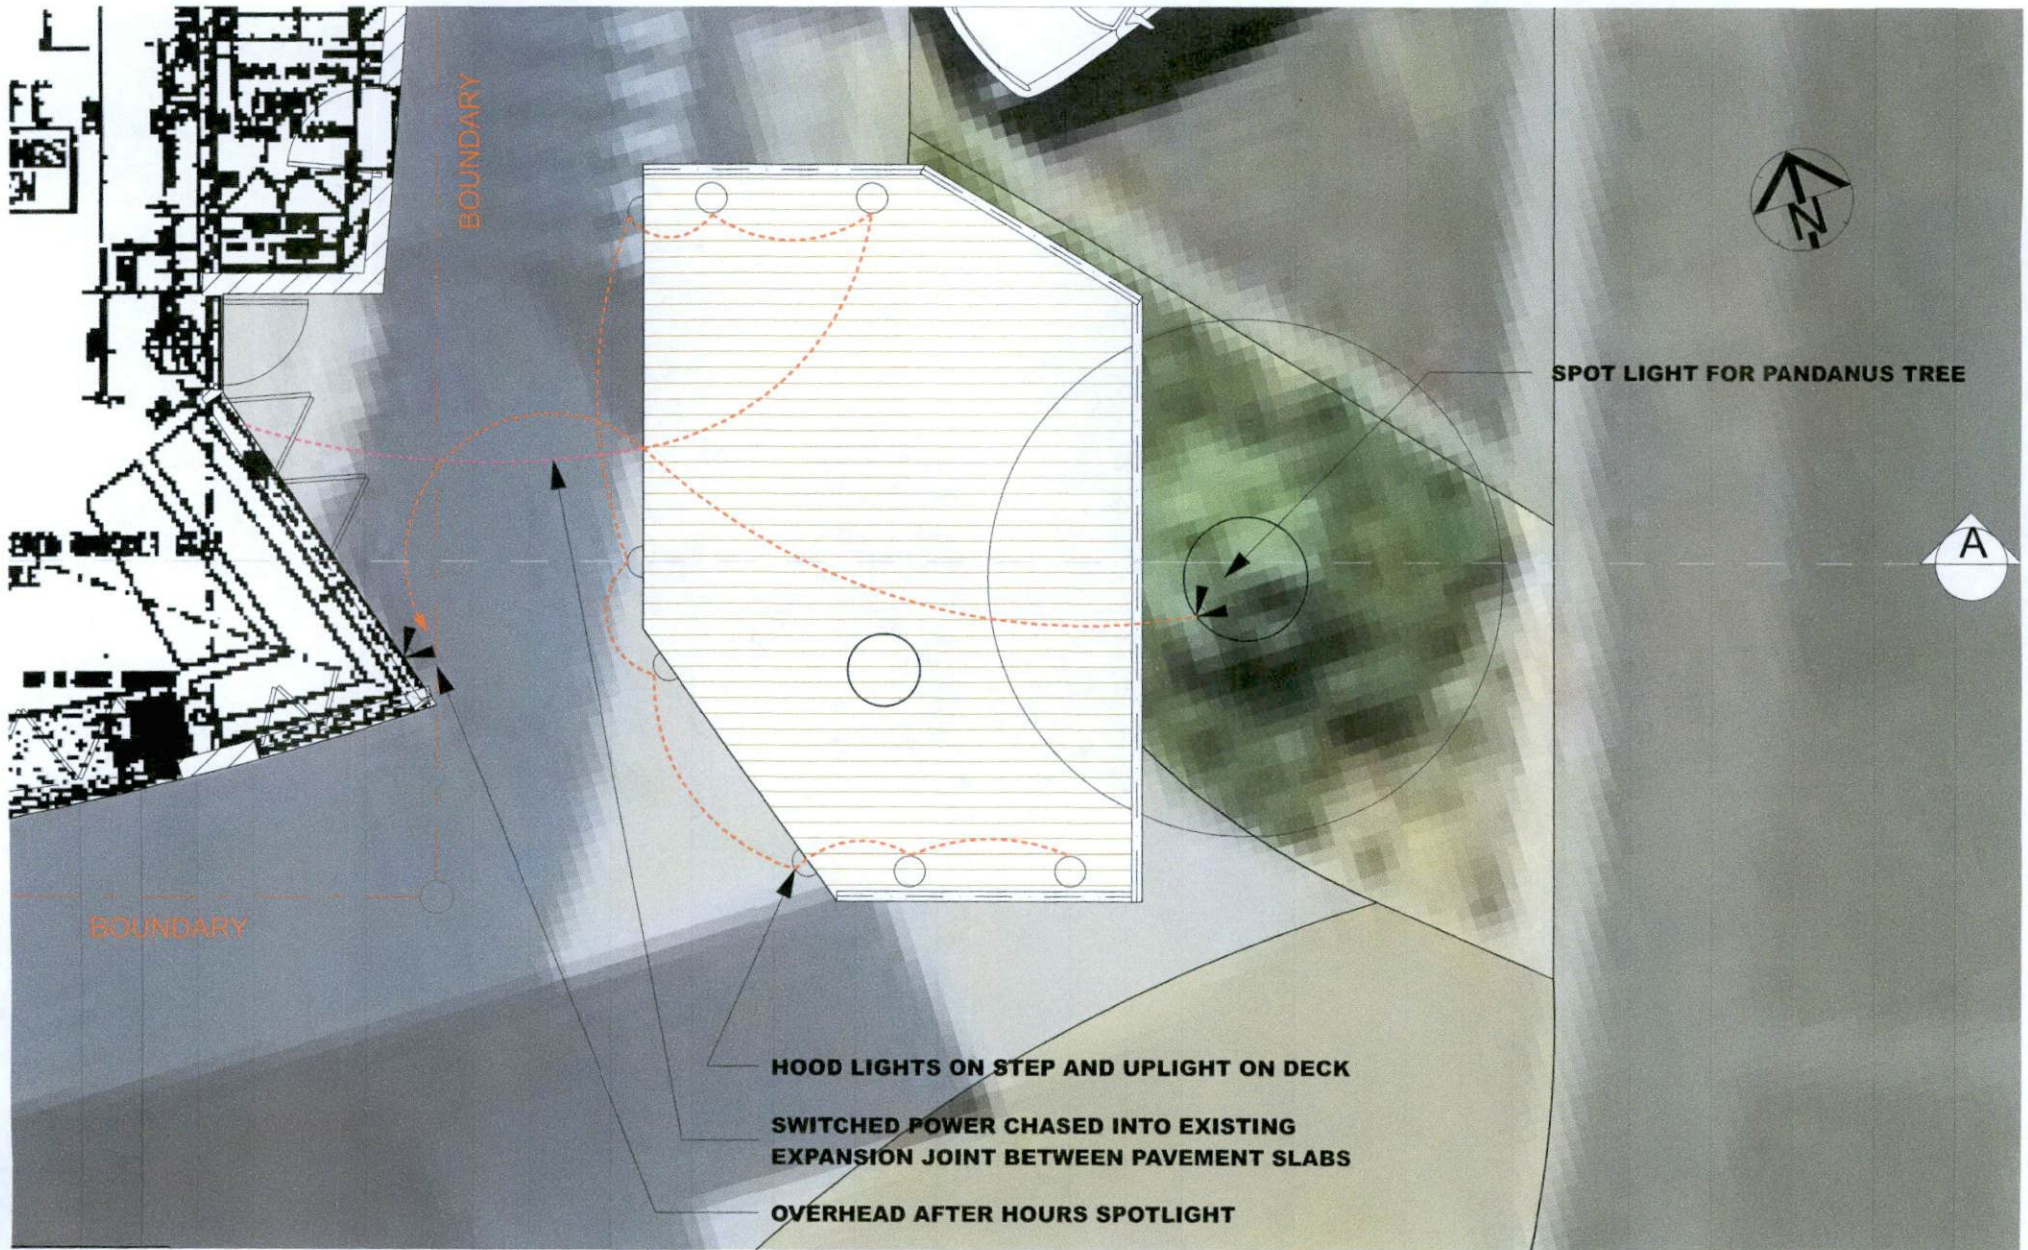

Issue: DA 2

PROPOSED CURBSIDE DINING DECK

Electrical Plan


Scale: 1:50@A3

Date: 31/04/2018

TARGA RESTAURANT, 11 MARVELL ST. BYRON BAY

Drawn By: JS

Drawing: 01.4

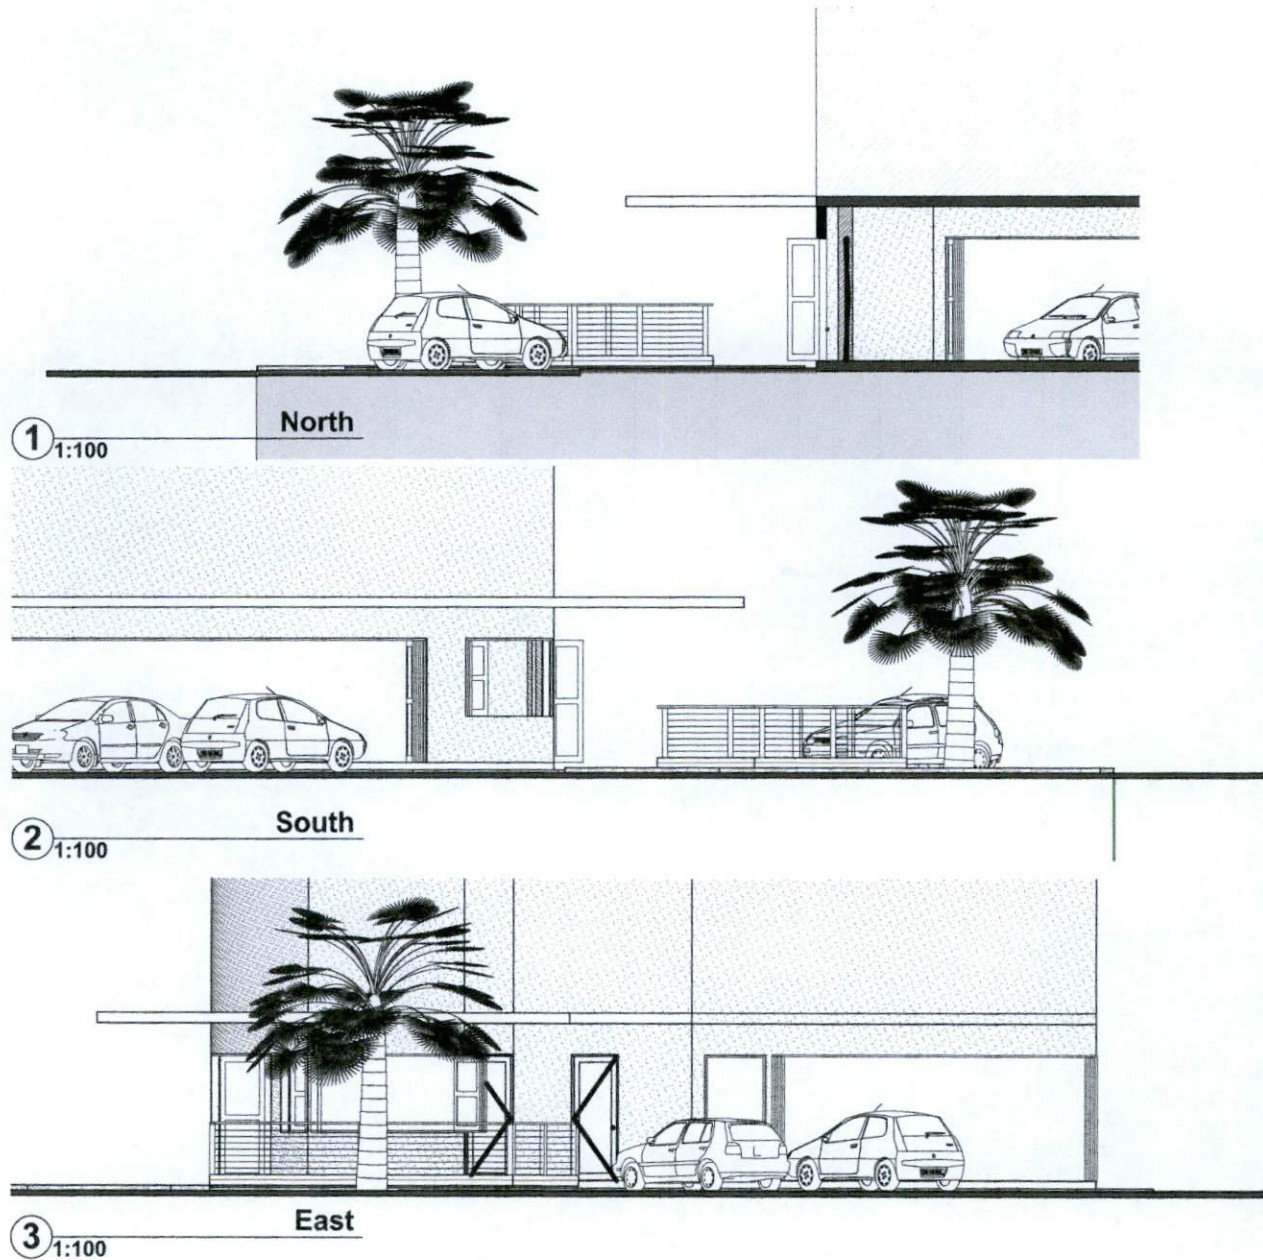

Issue: DA 2

PROPOSED CURBSIDE DINING DECK

Elevations


Scale: 1:100@A3

Date: 31/04/2018

TARGA RESTAURANT, 11 MARVELL ST. BYRON BAY

Drawn By: JS

Drawing: 02.1

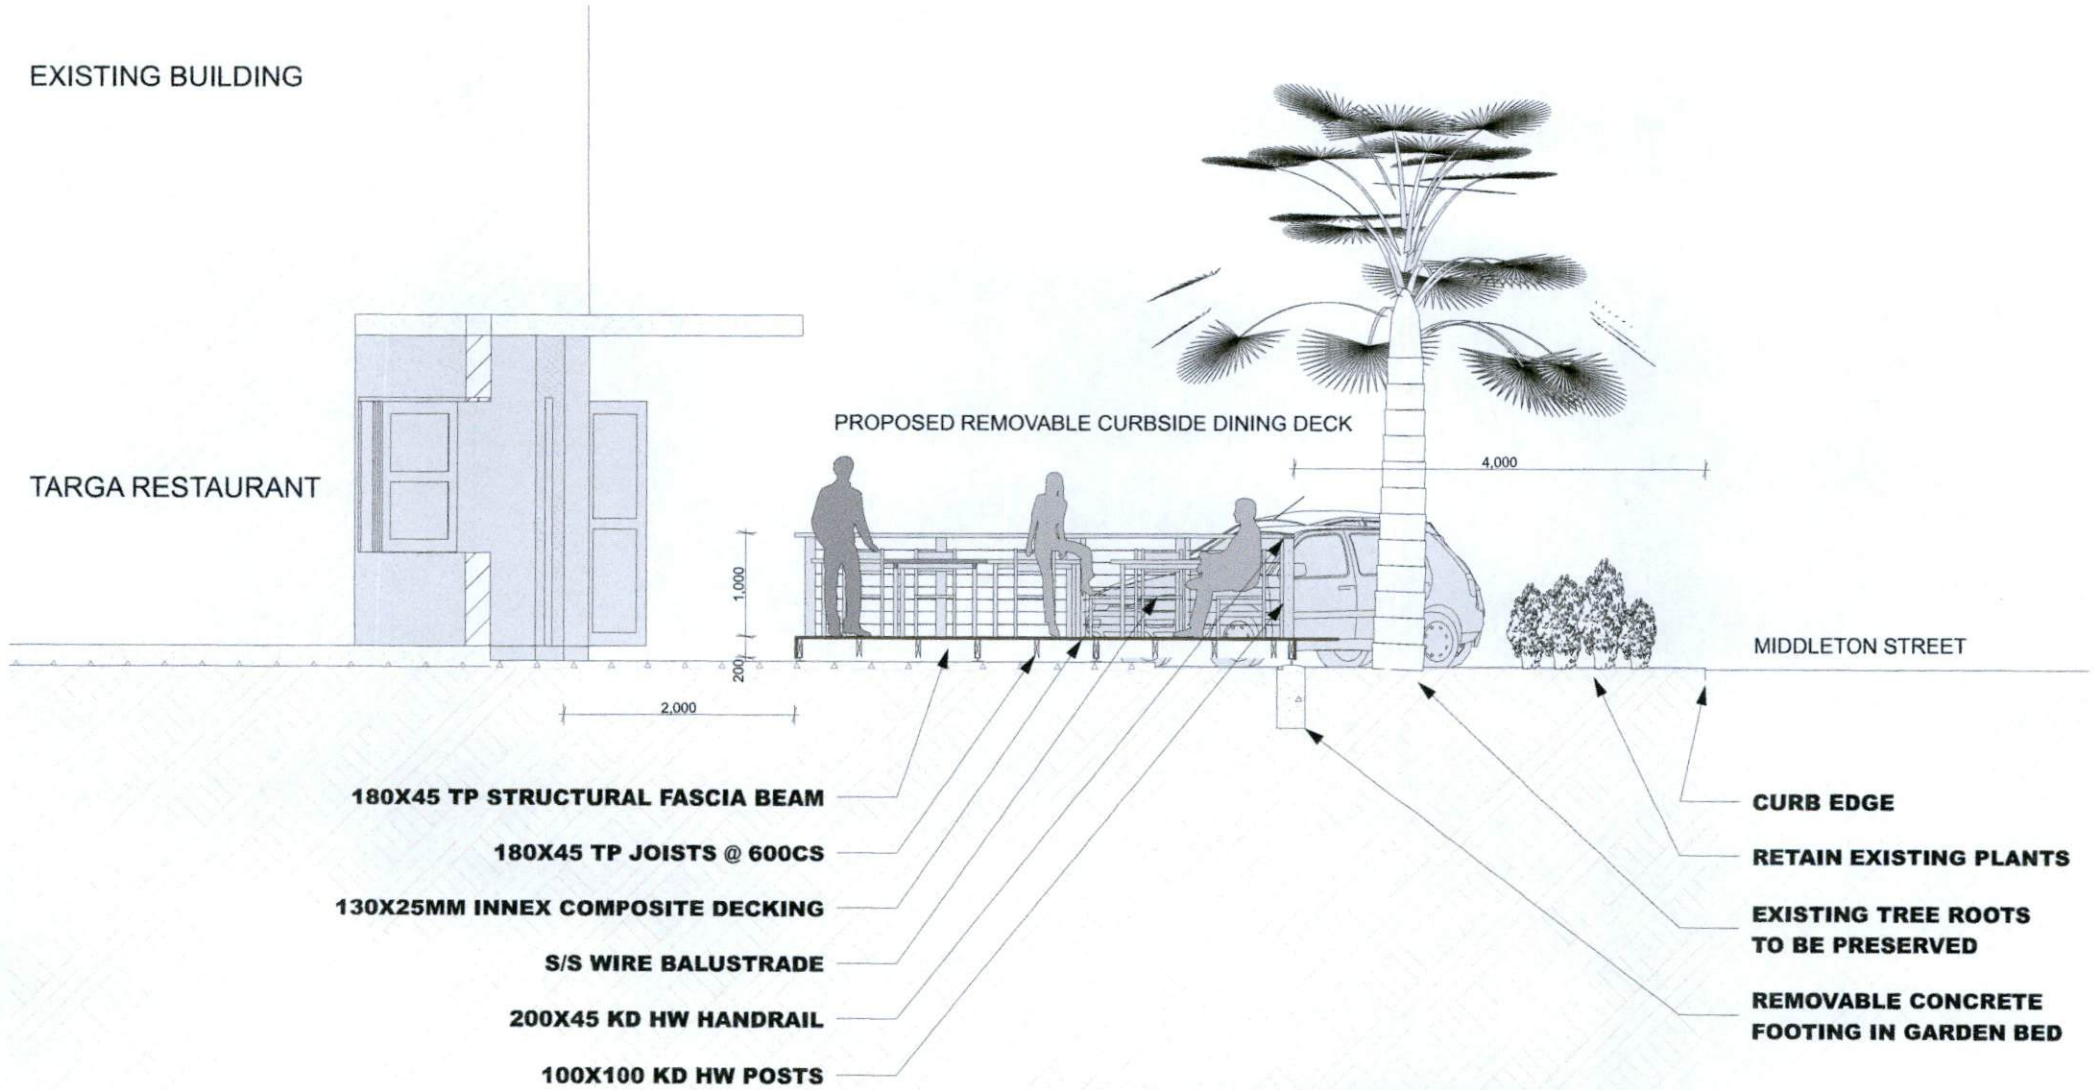

NOTE: ALL WORKS TO COMPLY WITH RELEVANT BCA AND TIMBER CODES

Issue: DA 2

PROPOSED CURBSIDE DINING DECK

Section A

Scale: 1:50 @ A3

Date: 31/04/2018

TARGA RESTAURANT, 11 MARVELL ST. BYRON BAY

Drawn By: JS

Drawing: 03.1